



LEAN-TO - INVERT SKYLIGHT
1 MOTOR

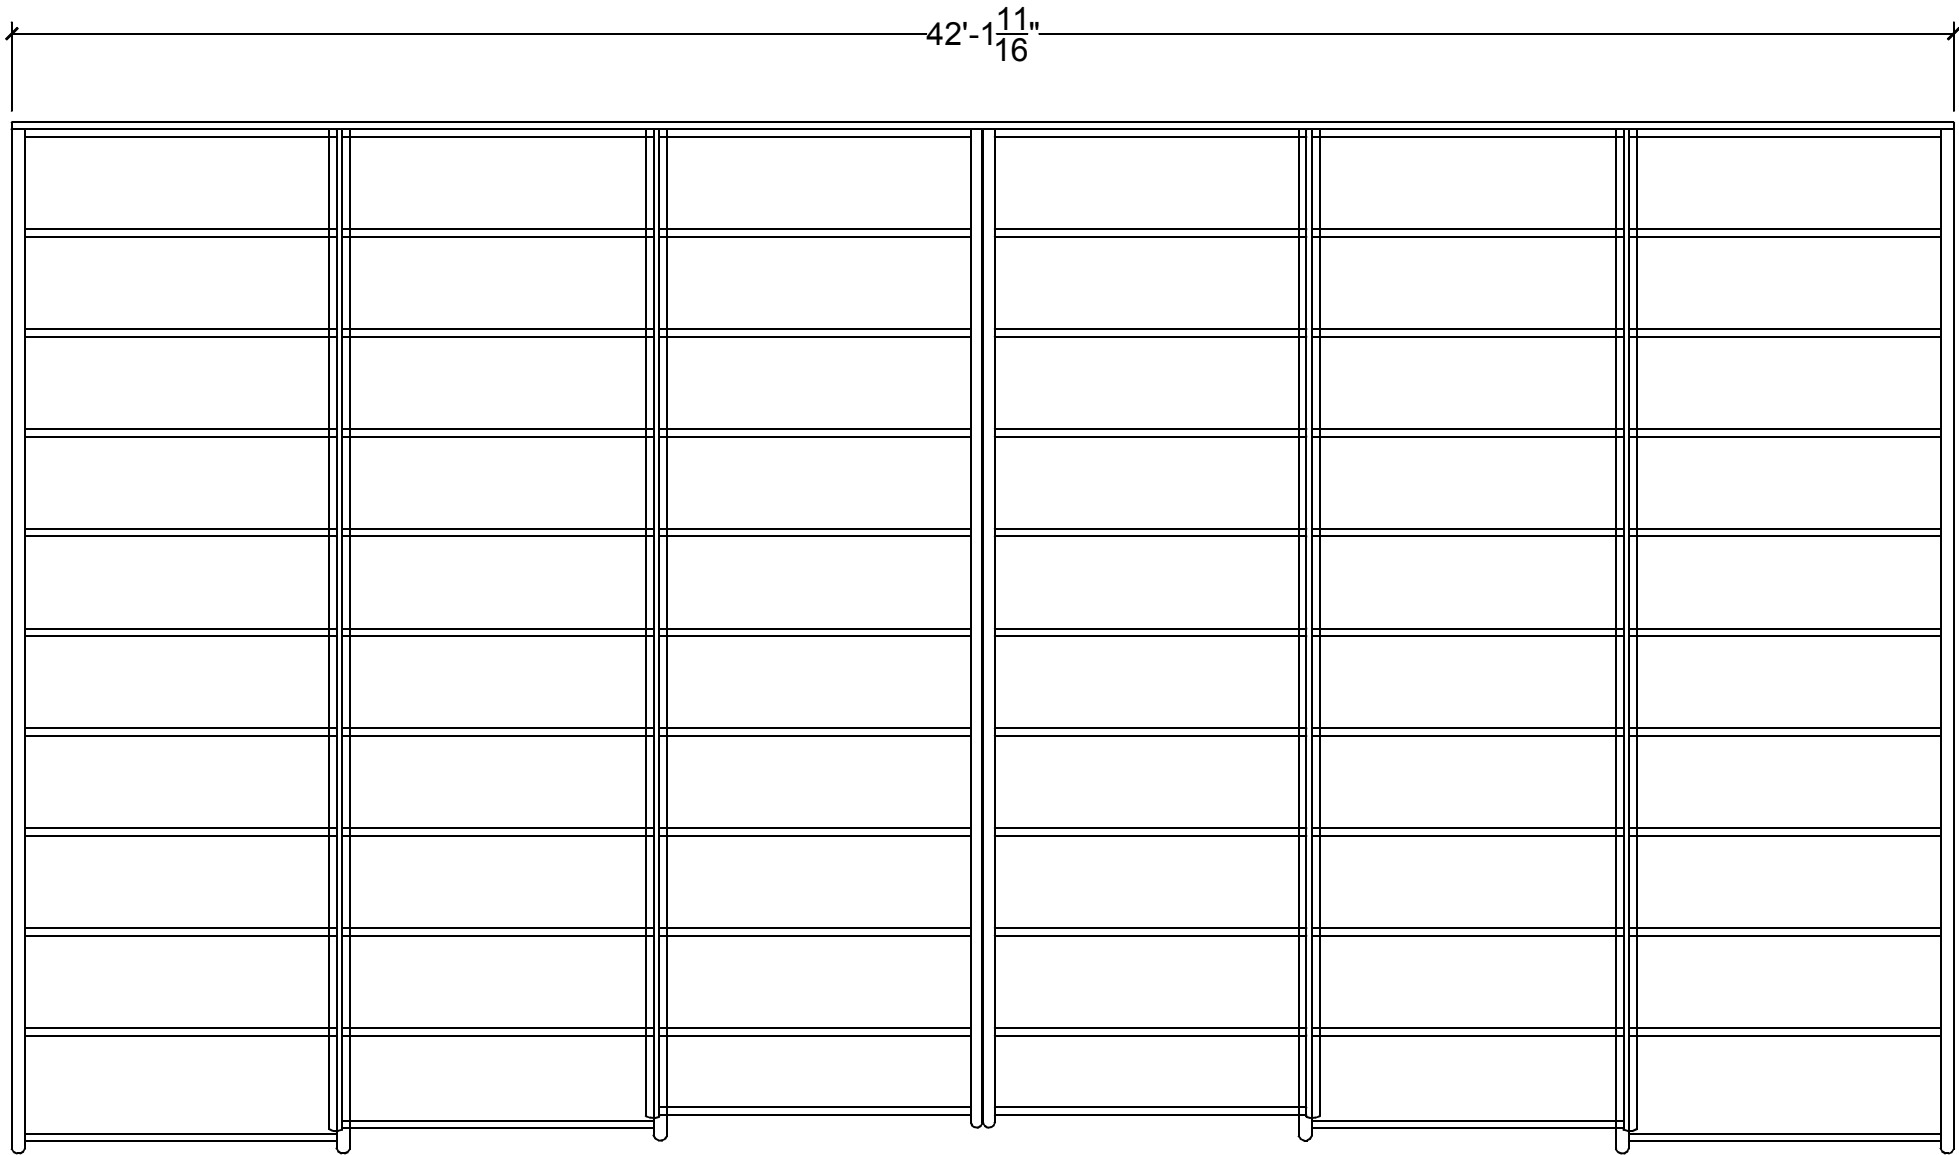


PLAN - CLOSED

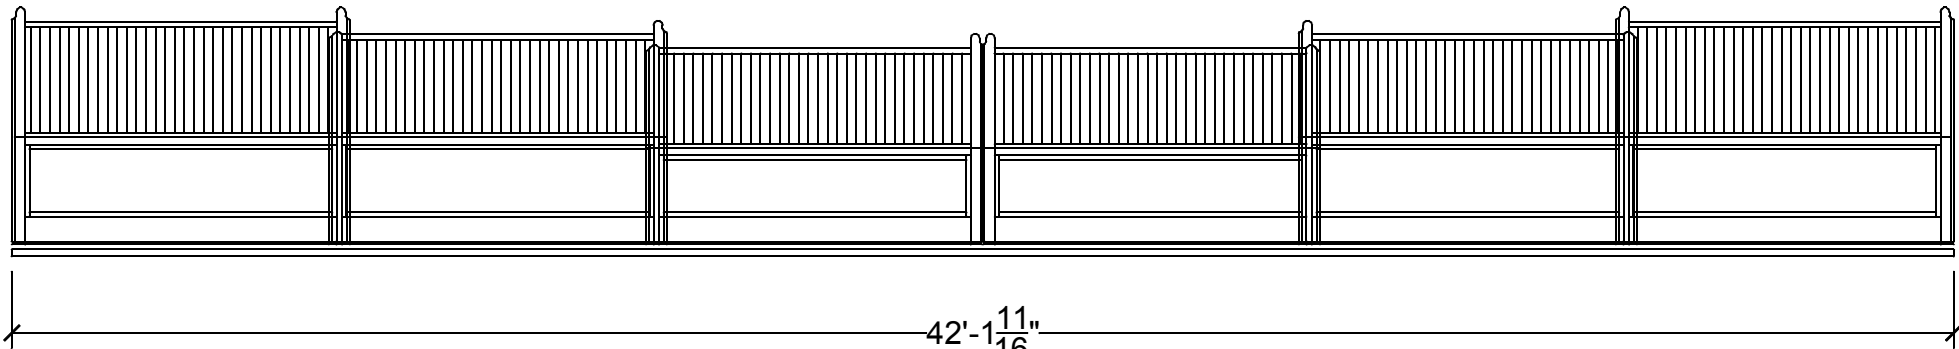


ELEVATION - CLOSED

DRAWING #: ILTS-01	JOB NAME & ADDRESS: INVERT LEAN-TO SKYLIGHT 1 MOTOR		SCALE: 1/4" = 1'-0"	ROLL - A - COVER INT ' L 696 AMITY ROAD, SUITE: L4 BETHANY, CT 06524
			SALESMAN:	
SHEET #: MOTOR 1 OF 10	ORIGINATION	REVISED	REVISED	DRAWN BY: K. TAYLOR
	DATE: 09-16-25			
				Tel: 203-393-7292 Fax: 203-286-2012 www.rollacover.com

LEAN-TO - INVERT SKYLIGHT
1 MOTOR

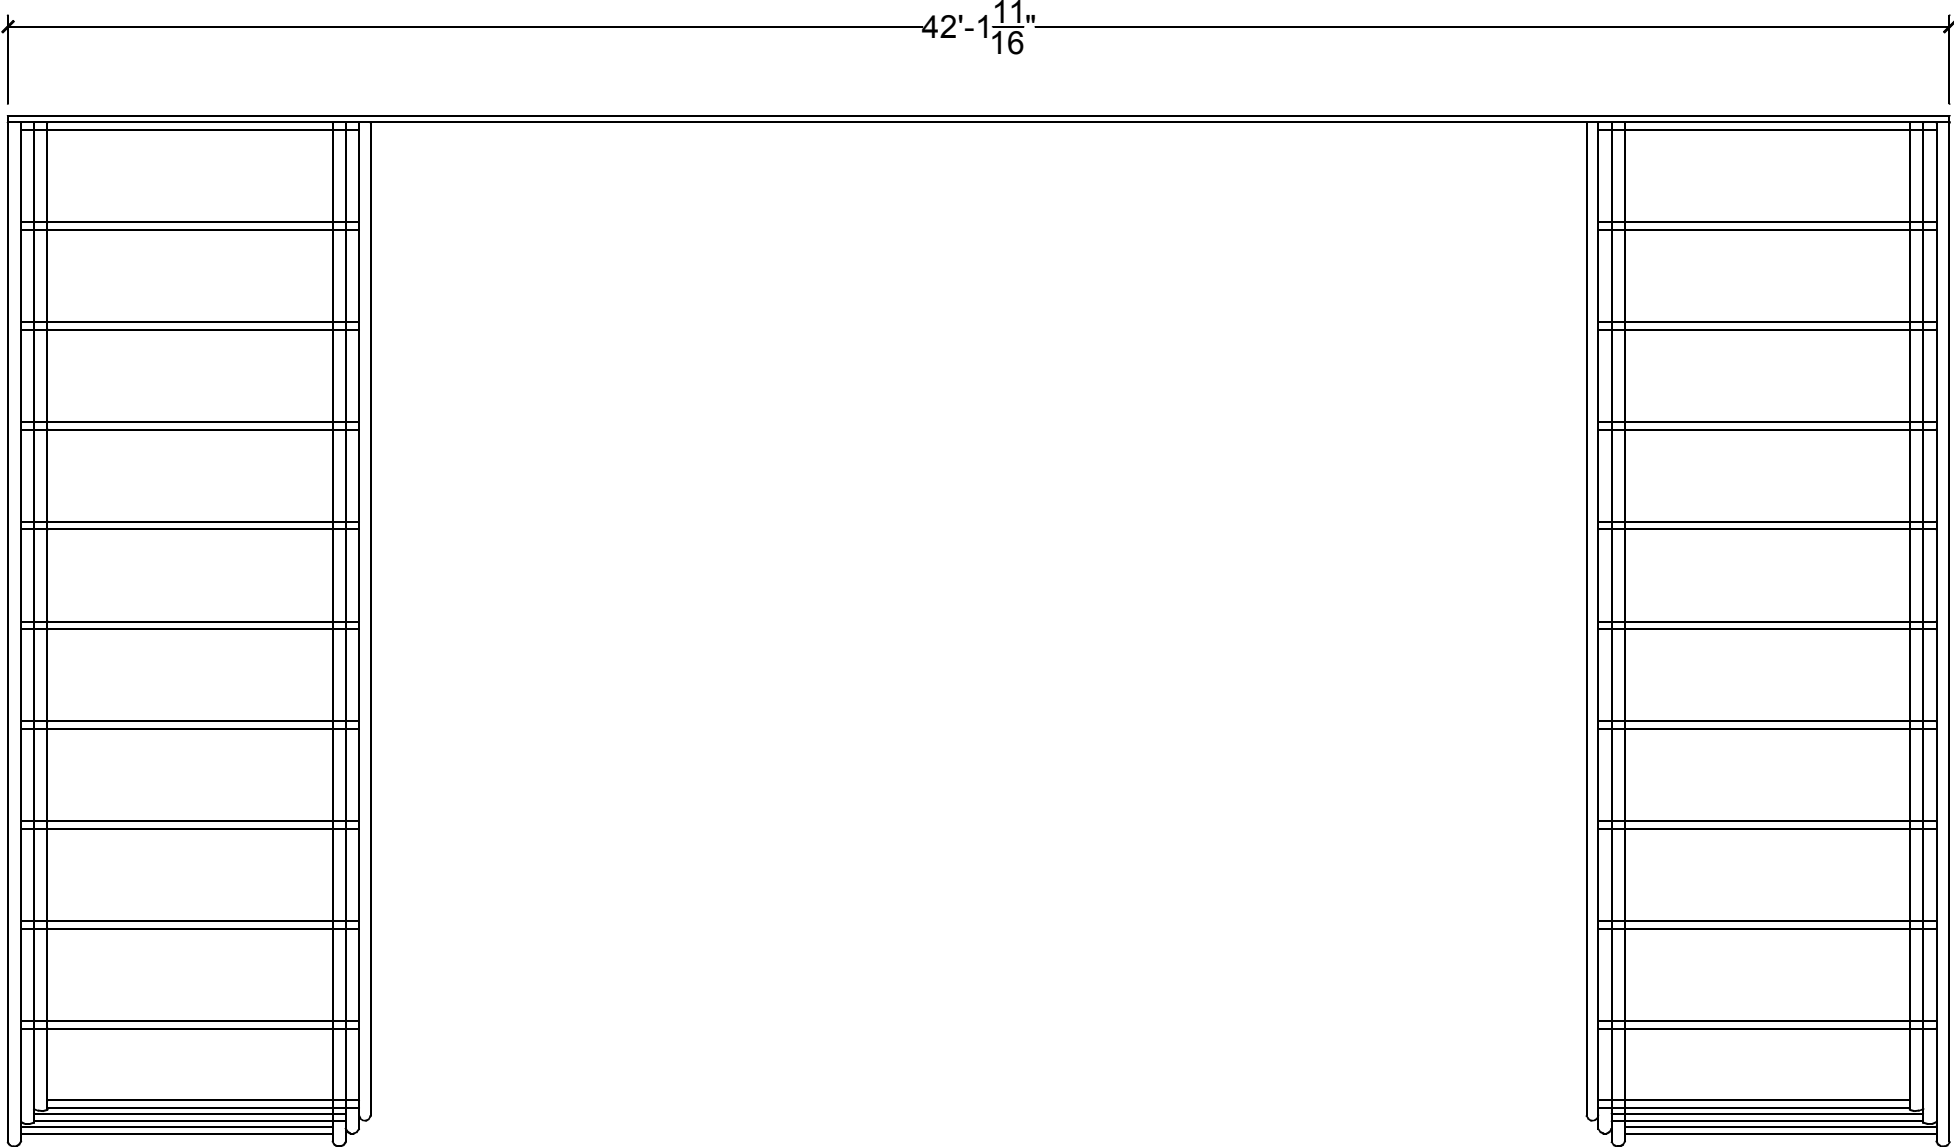


PLAN - OPEN

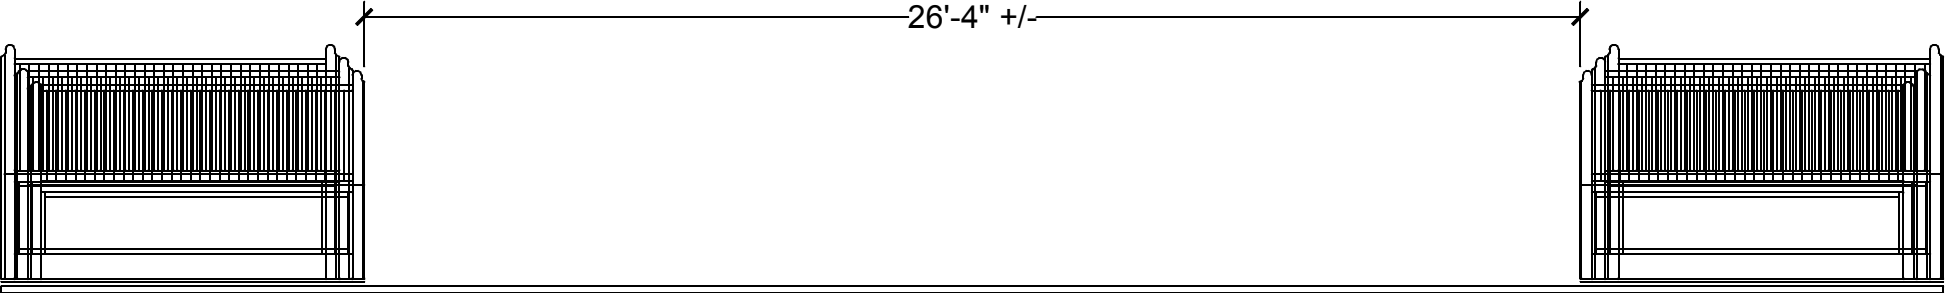


ELEVATION- OPEN

DRAWING # ILTS-01	JOB NAME & ADDRESS: INVERT LEAN-TO SKYLIGHT 1 MOTOR		SCALE: 1/4" = 1'-0"	ROLL - A - COVER INT ' L 696 AMITY ROAD, SUITE: L4 BETHANY, CT 06524 Tel: 203-393-7292 Fax: 203-286-2012 www.rollacover.com
	ORIGINATION REVISED REVISED REVISED		SALESMAN:	
SHEET # MOTOR 2 OF 10	DATE: 09-16-25		DRAWN BY: K. TAYLOR	


LEAN-TO - INVERT SKYLIGHT
1 MOTOR

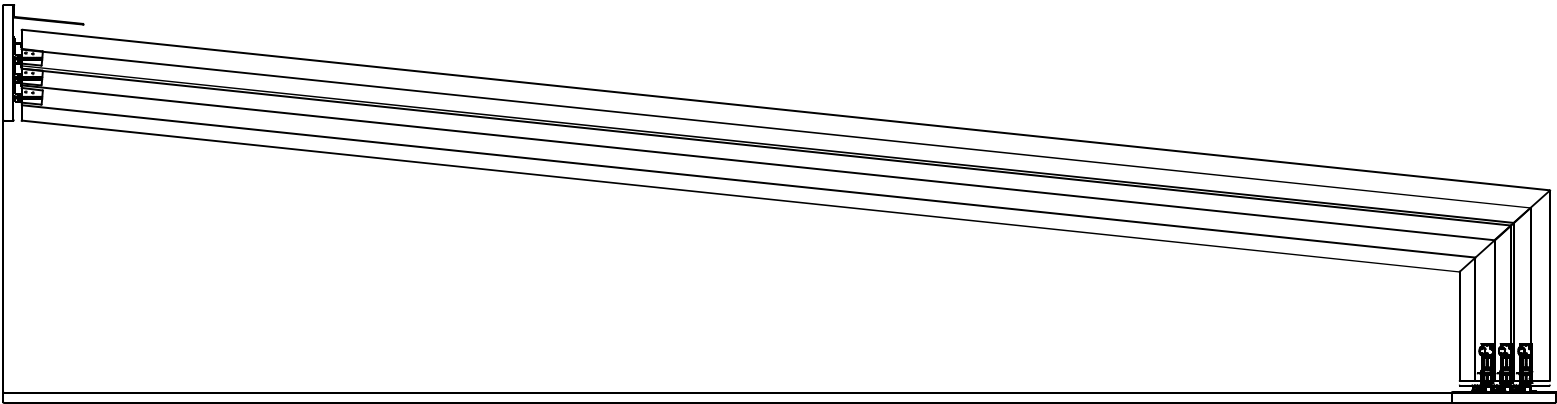

SECTION

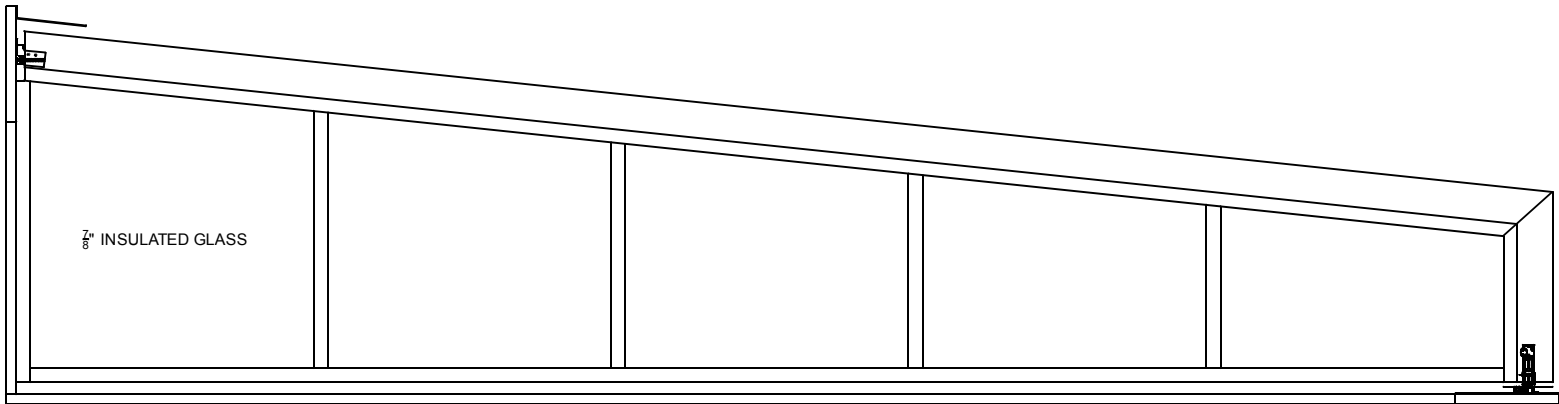


LEFT ELEVATION

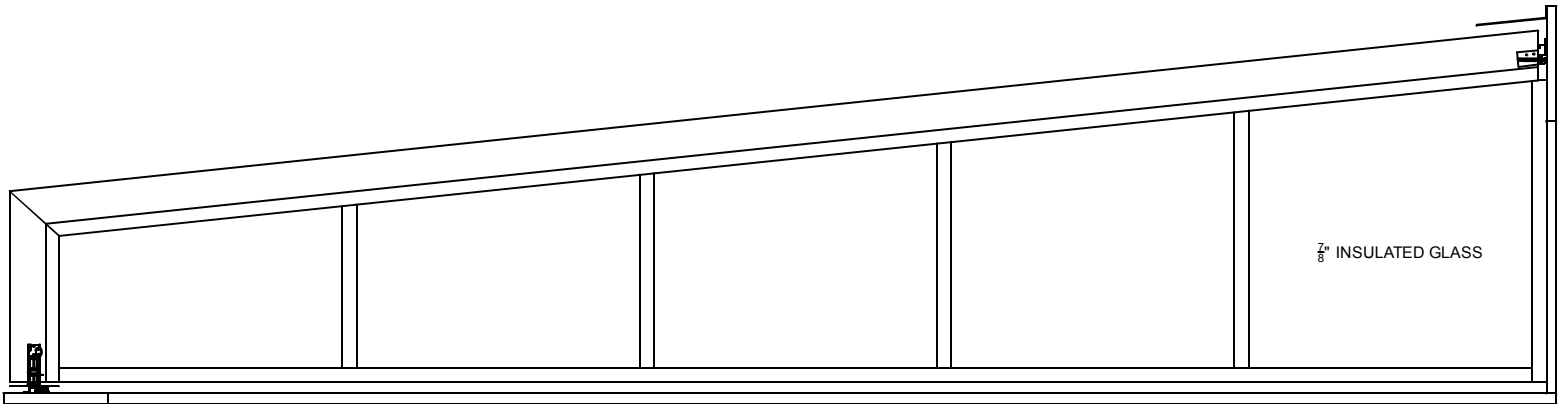

RIGHT ELEVATION

DRAWING #: ILTS-01	JOB NAME & ADDRESS: INVERT LEAN-TO SKYLIGHT 1 MOTOR	SCALE: 1/4" = 1'-0"	ROLL - A - COVER INT ' L 696 AMITY ROAD, SUITE: L4 BETHANY, CT 06524 Tel: 203-393-7292 Fax: 203-286-2012 www.rollacover.com
SHEET #: MOTOR 3 OF 10	ORIGINATION DATE: 09-16-25	SALESMAN:	
		DRAWN BY: K.TAYLOR	


LEAN-TO - INVERT SKYLIGHT
1 MOTOR

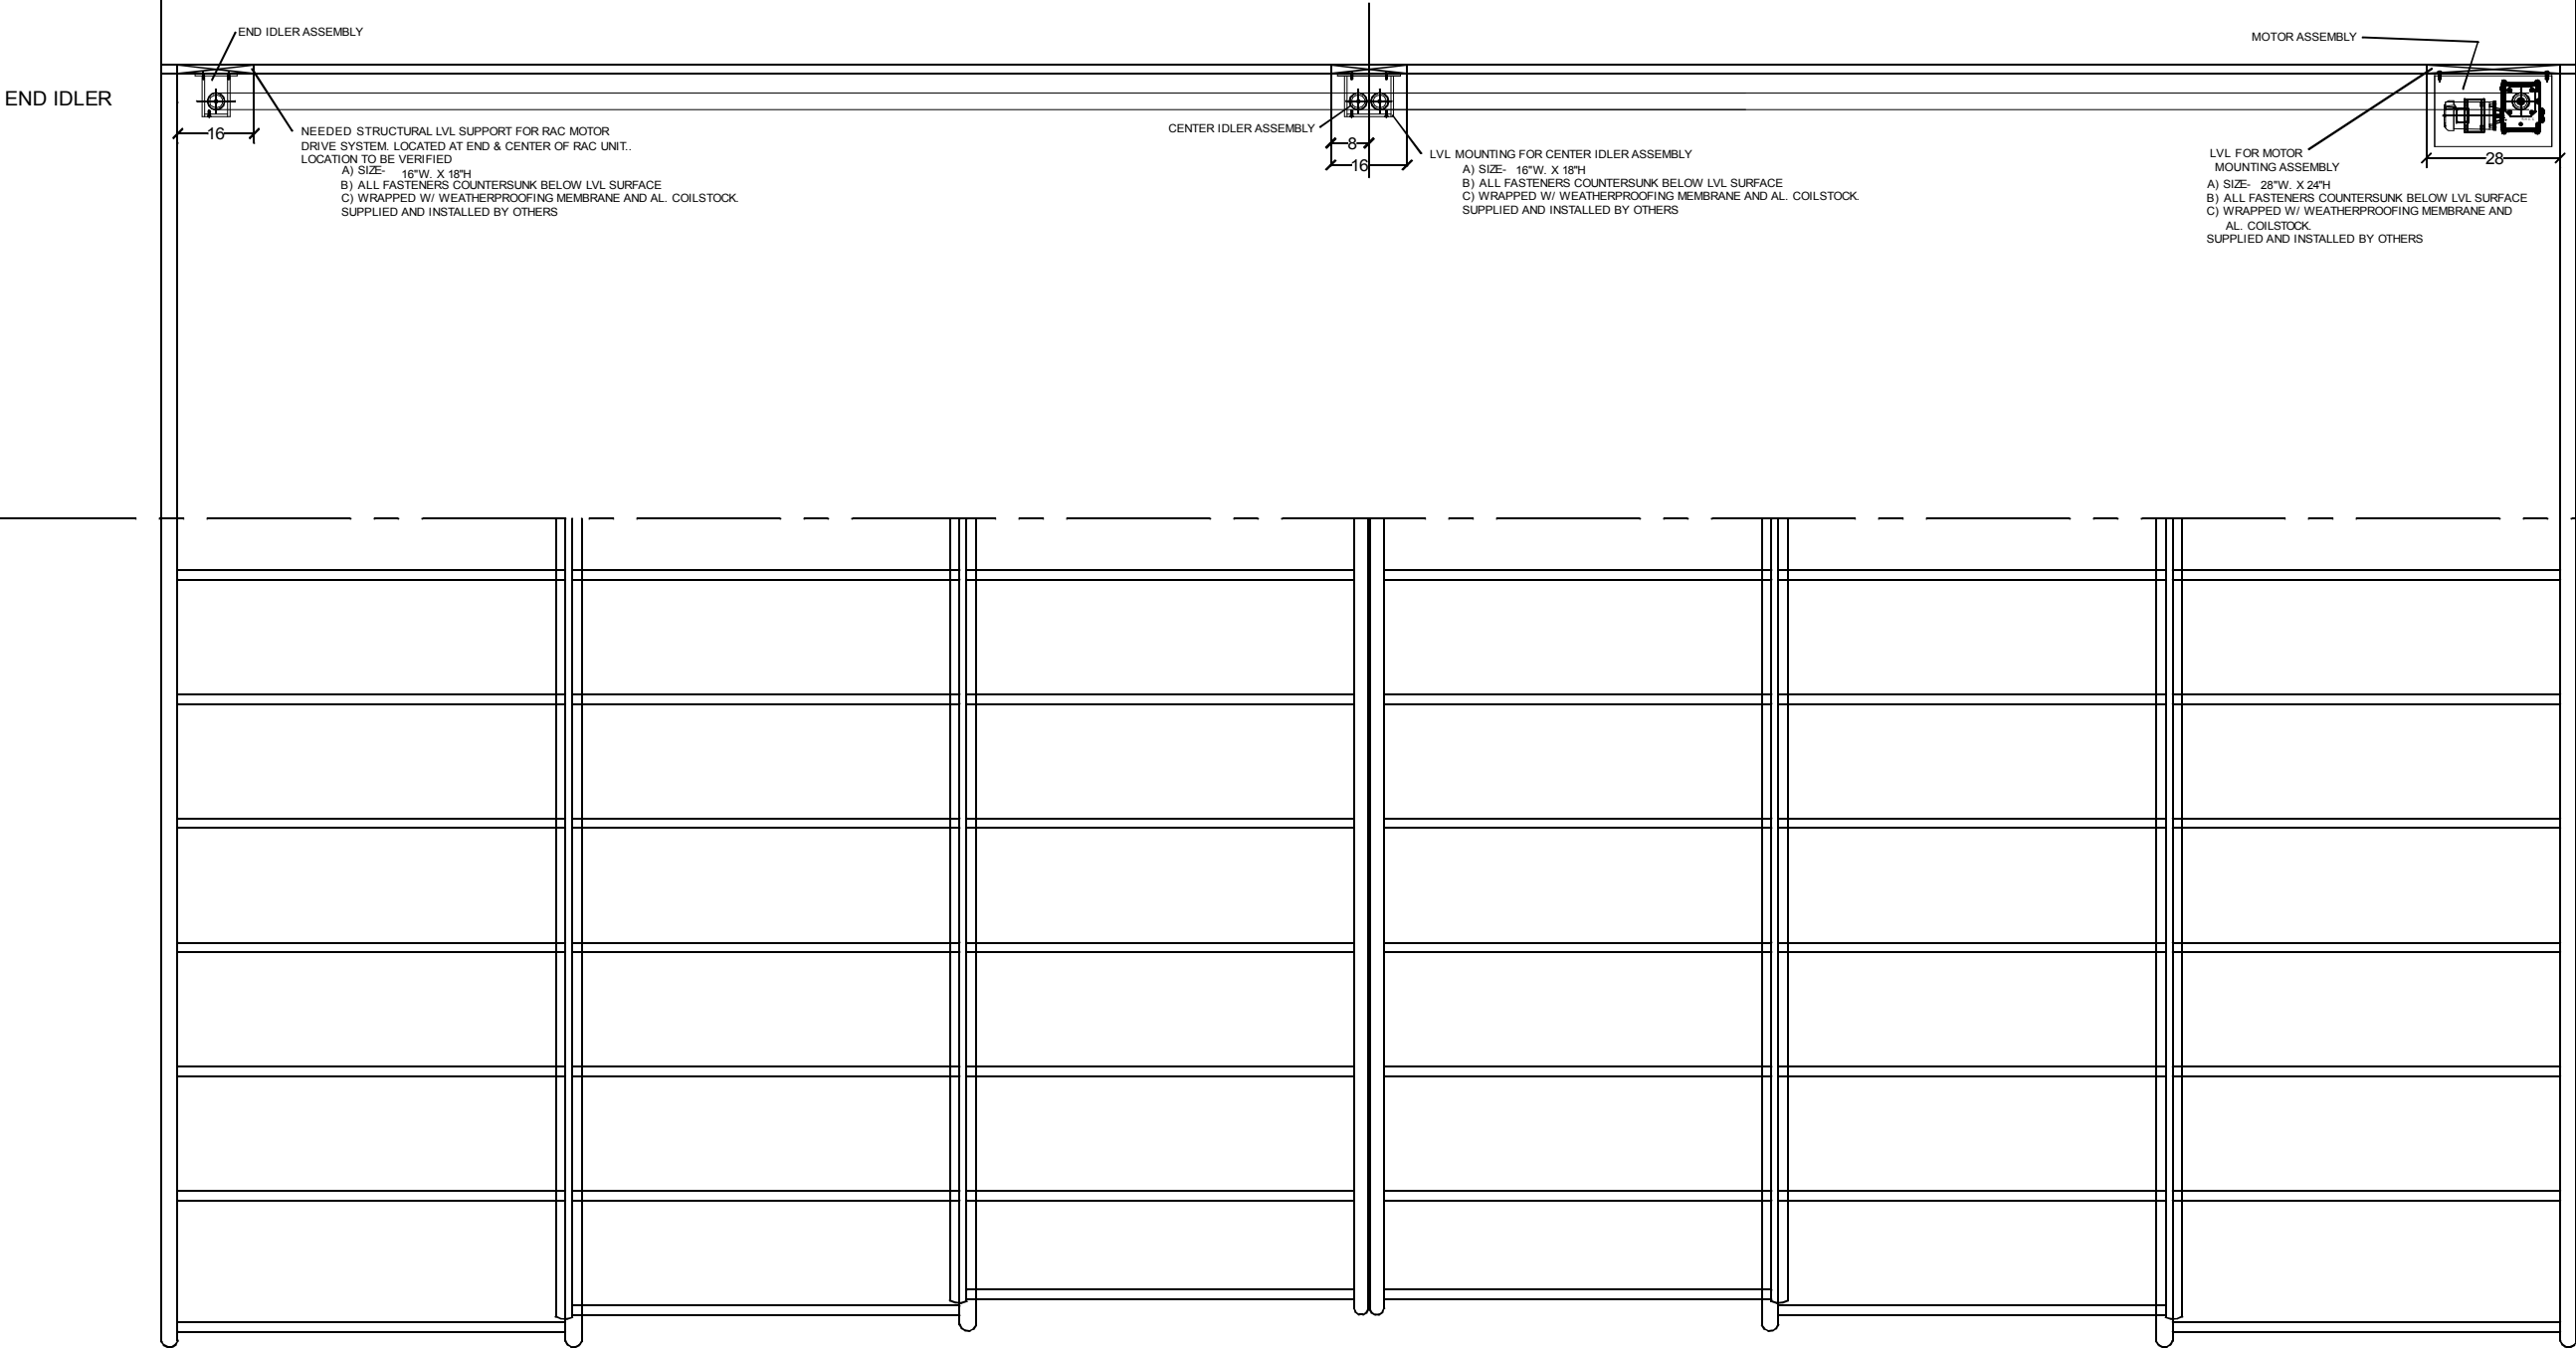

PLAN - CLOSED WITH/ MOTOR

DRAWING #: ILTS-01	JOB NAME & ADDRESS: INVERT LEAN-TO SKYLIGHT 1 MOTOR		SCALE: $\frac{1}{4}" = 1'-0"$	ROLL - A - COVER INT ' L 696 AMITY ROAD, SUITE: L4 BETHANY, CT 06524 Tel: 203-393-7292 Fax: 203-286-2012 www.rollacover.com
	SHEET #: MOTOR 4 OF 10	ORIGINATION DATE: 09-16-25	SALESMAN: DRAWN BY: K. TAYLOR	

LEAN-TO - INVERT SKYLIGHT
1 MOTOR

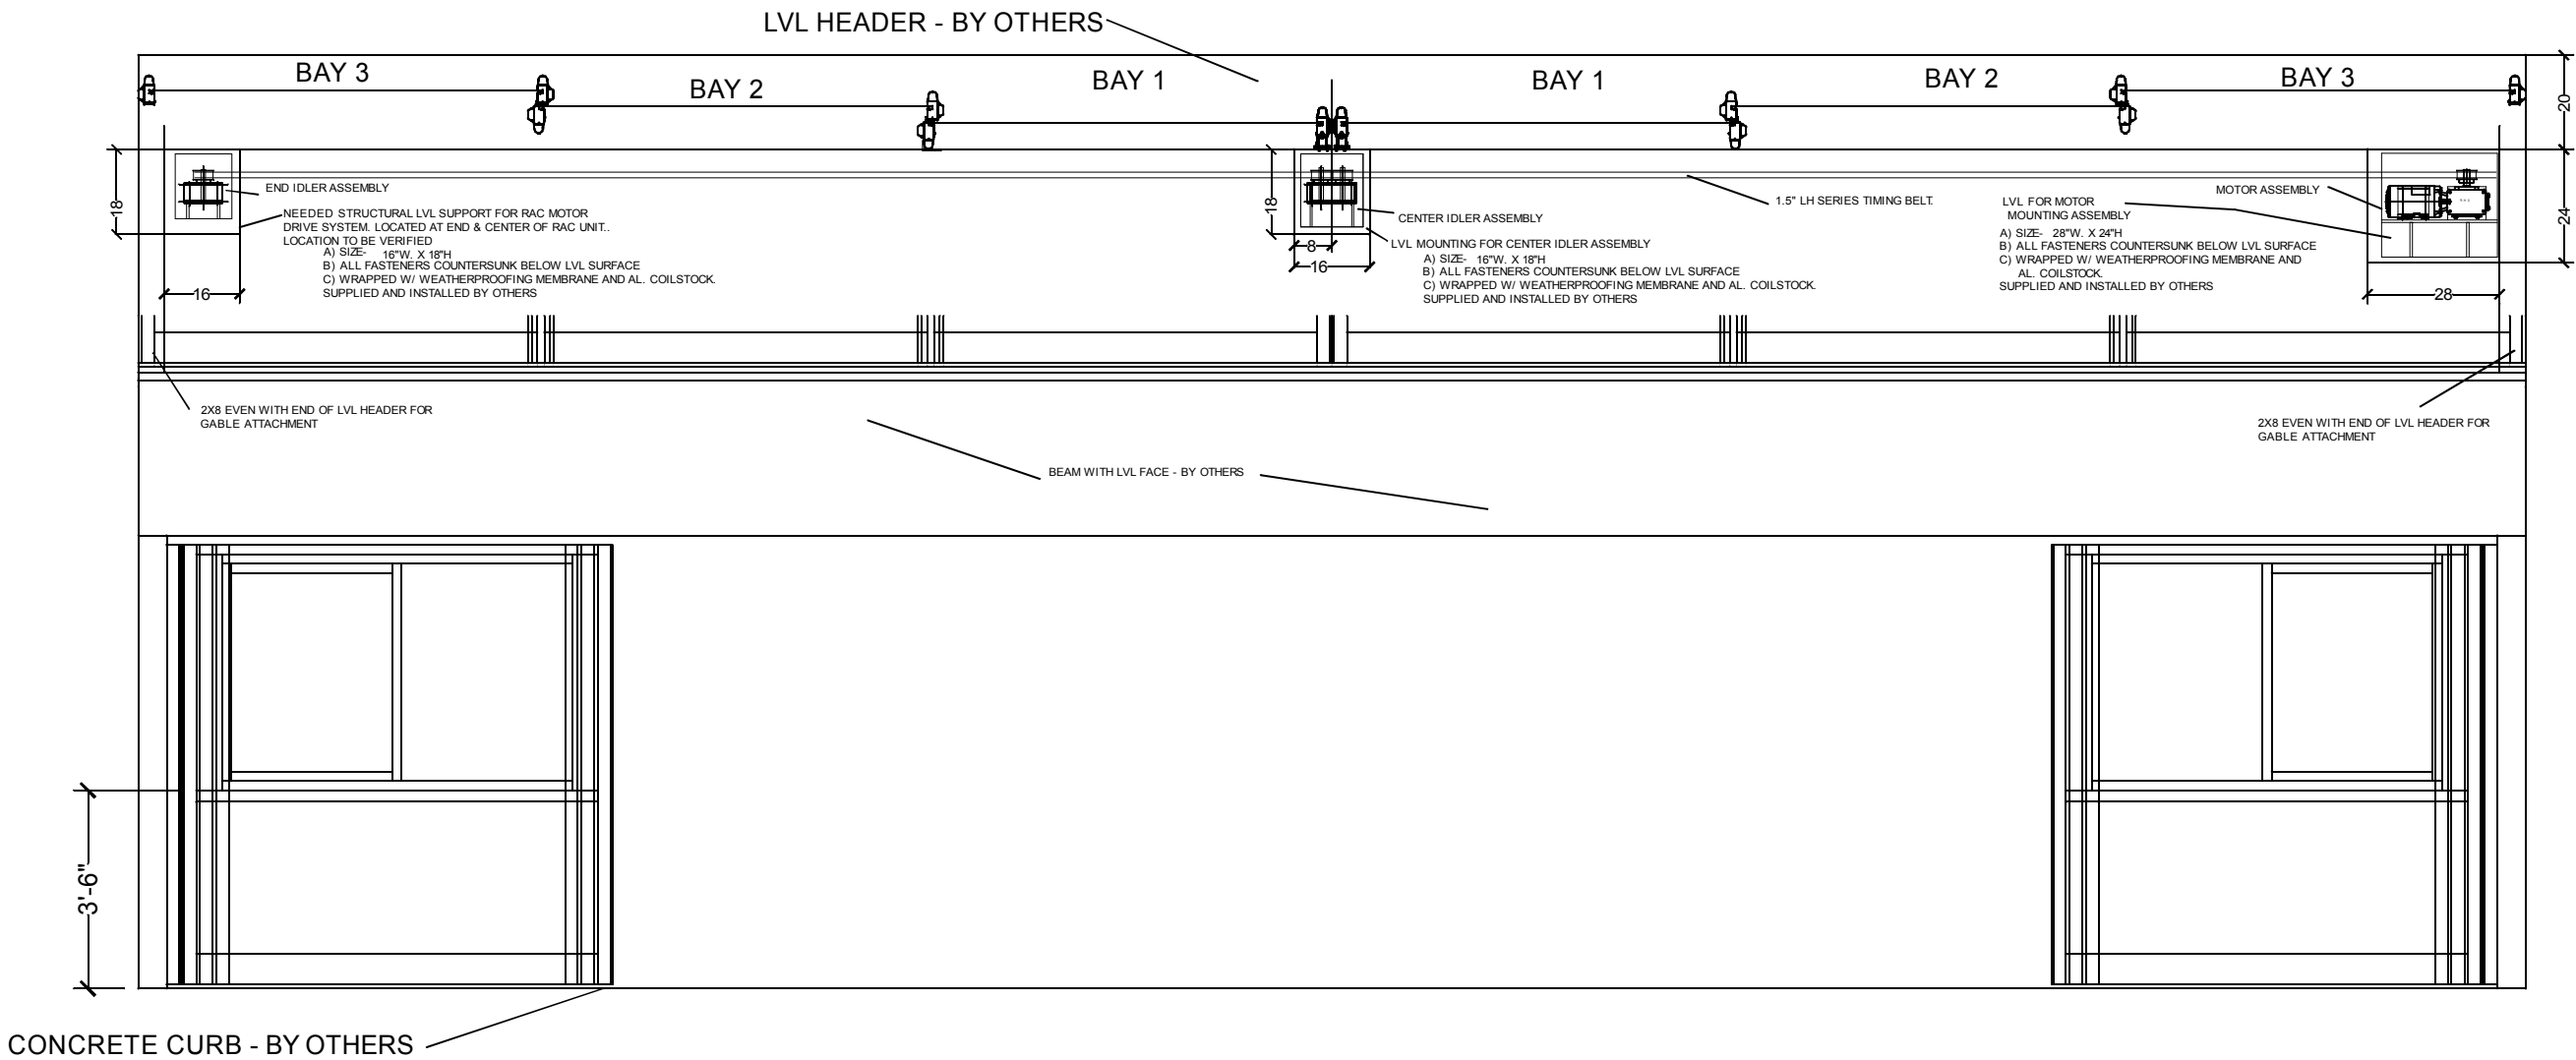


FRONT ELEVATION - OPEN W/ MOTOR

DRAWING #: ILTS-01	JOB NAME & ADDRESS: INVERT LEAN-TO SKYLIGHT 1 MOTOR	SCALE: 1/4" = 1'-0"	ROLL - A - COVER INT'L 696 AMITY ROAD, SUITE: L4 BETHANY, CT 06524
SHEET # MOTOR 5 OF 10	ORIGINATION DATE: 09-16-25	SALESMAN: DRAWN BY: K.TAYLOR	
Tel: 203-393-7292 Fax: 203-286-2012			www.rollacover.com

LEAN-TO - INVERT SKYLIGHT
1 MOTOR


REAR SUPPORT WALL
& LVL - BY OTHERS

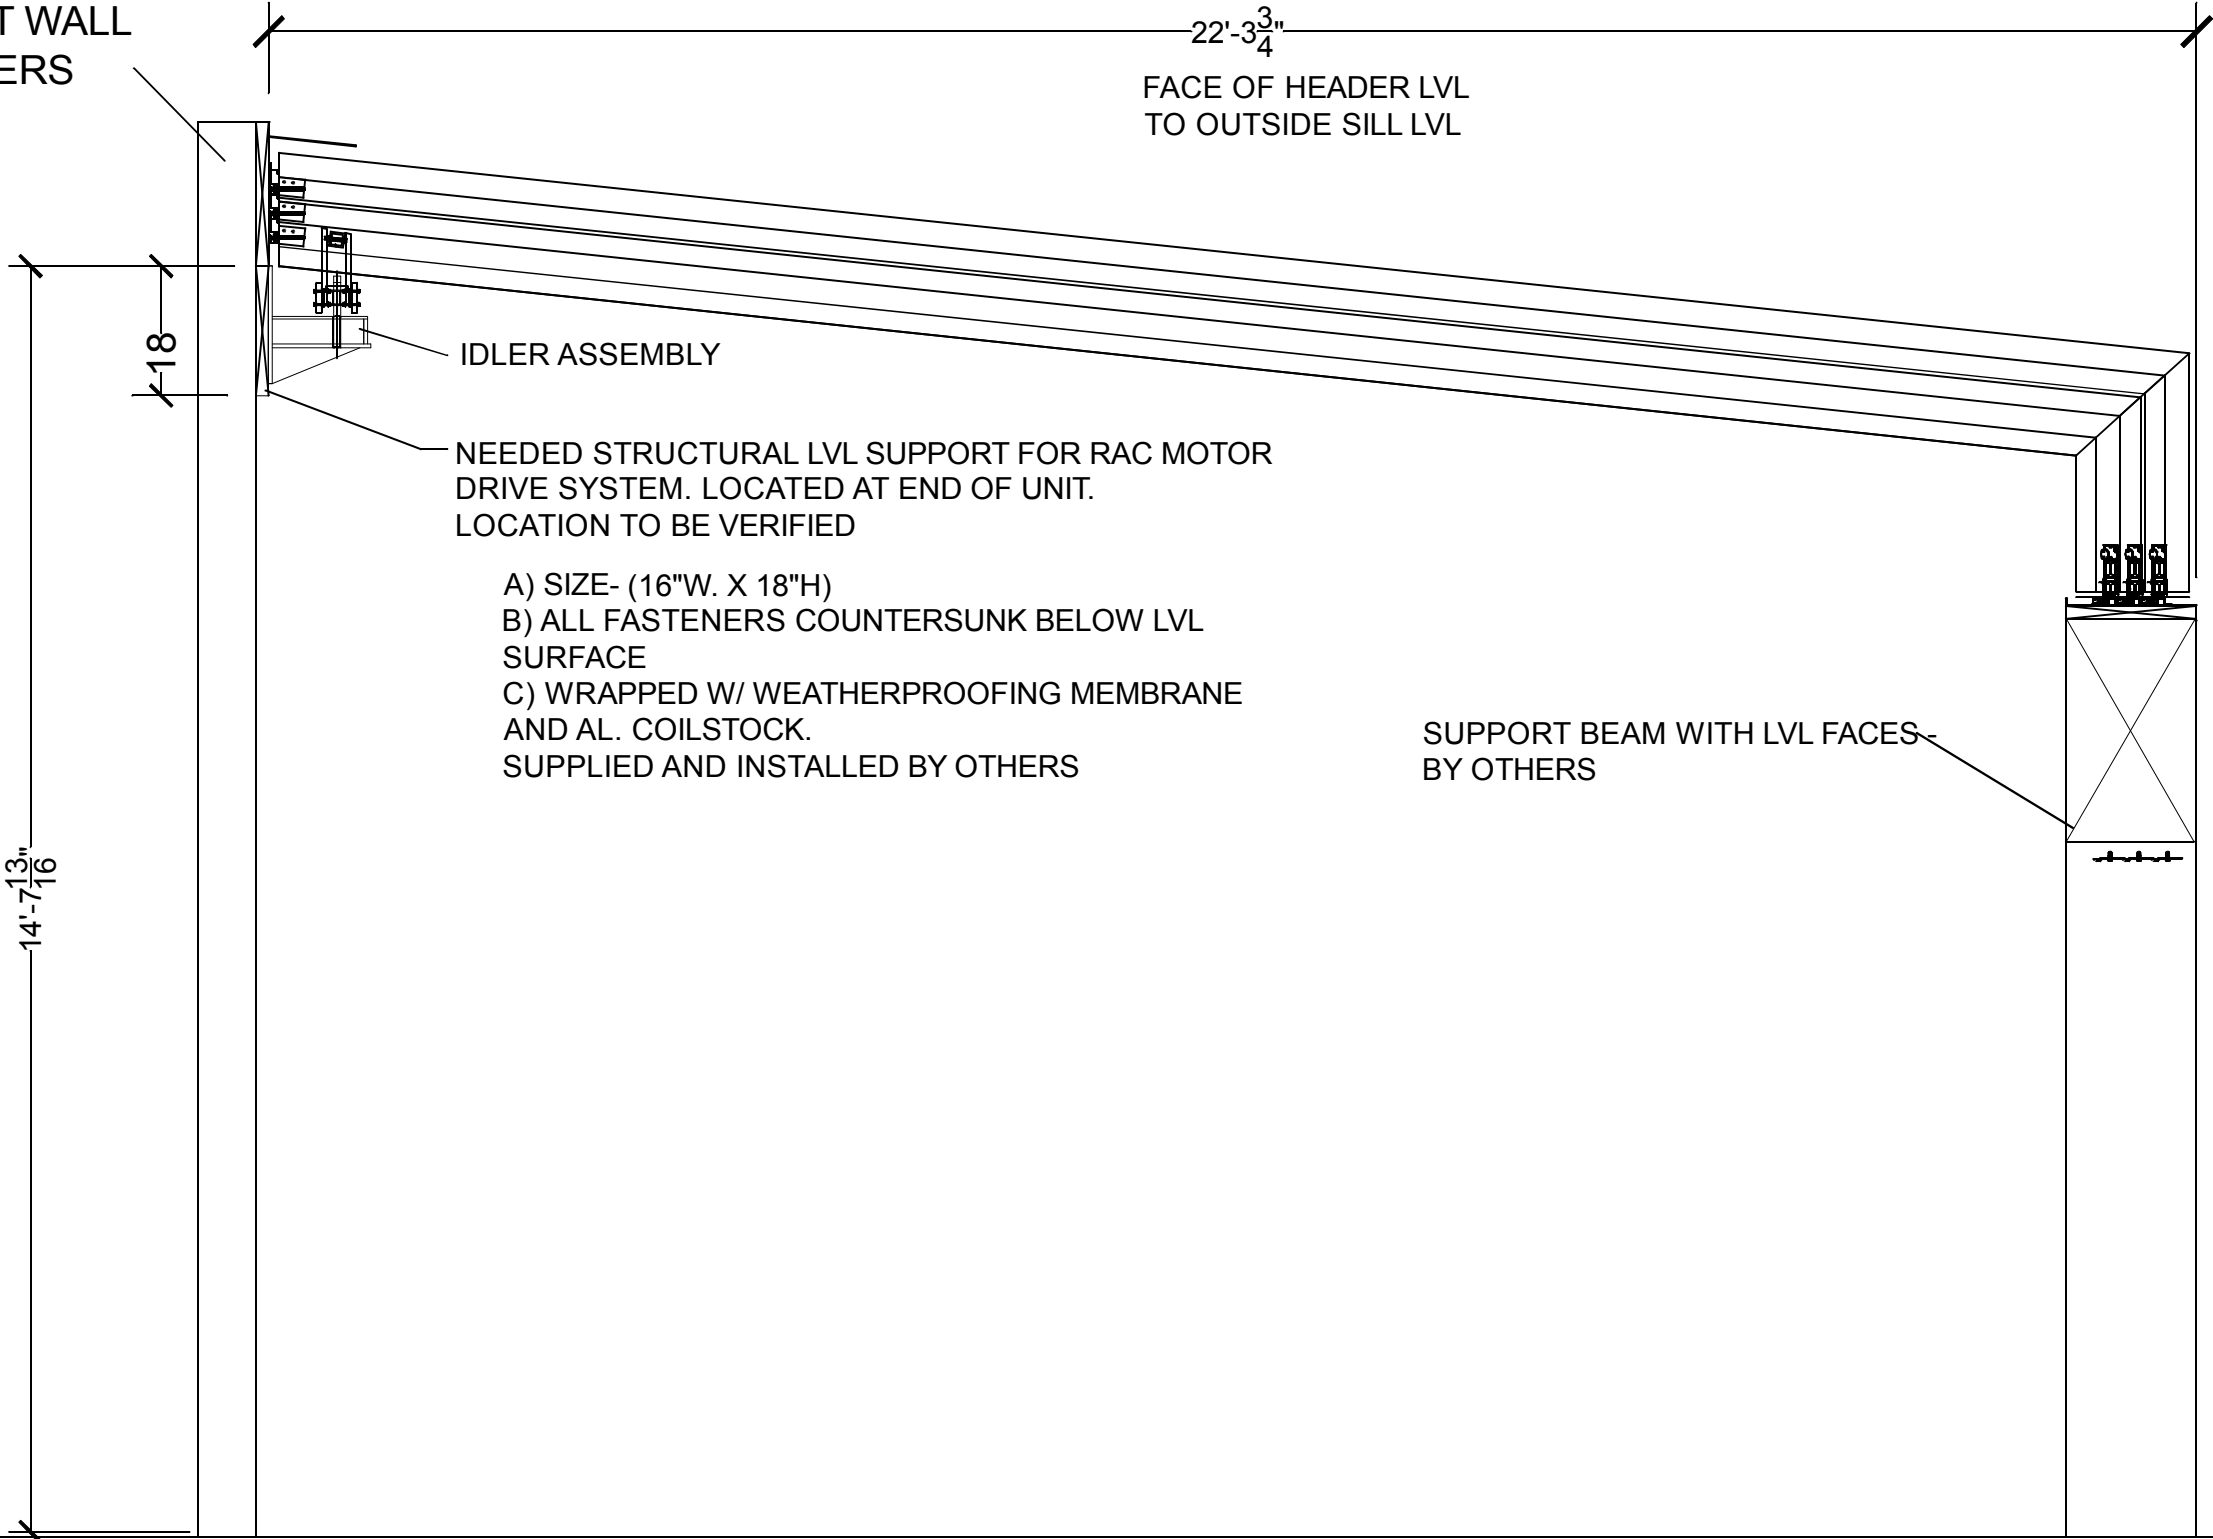

LEFT SECTION W/ OPENER

DRAWING #: ILTS-01	JOB NAME & ADDRESS: INVERT LEAN-TO SKYLIGHT 1 MOTOR		SCALE: 1/4" = 1'-0"		ROLL-A-COVER INT'L 696 AMITY ROAD, SUITE: L4 BETHANY, CT 06524 Tel: 203-393-7292 Fax: 203-286-2012 www.rollacover.com	
	SHEET #: MOTOR 6 OF 10	ORIGINATOR DATE: 09-16-25	REVISED	REVISED	REVISED	SALESMAN DRAWN BY: K.TAYLOR

LEAN-TO - INVERT SKYLIGHT
1 MOTOR

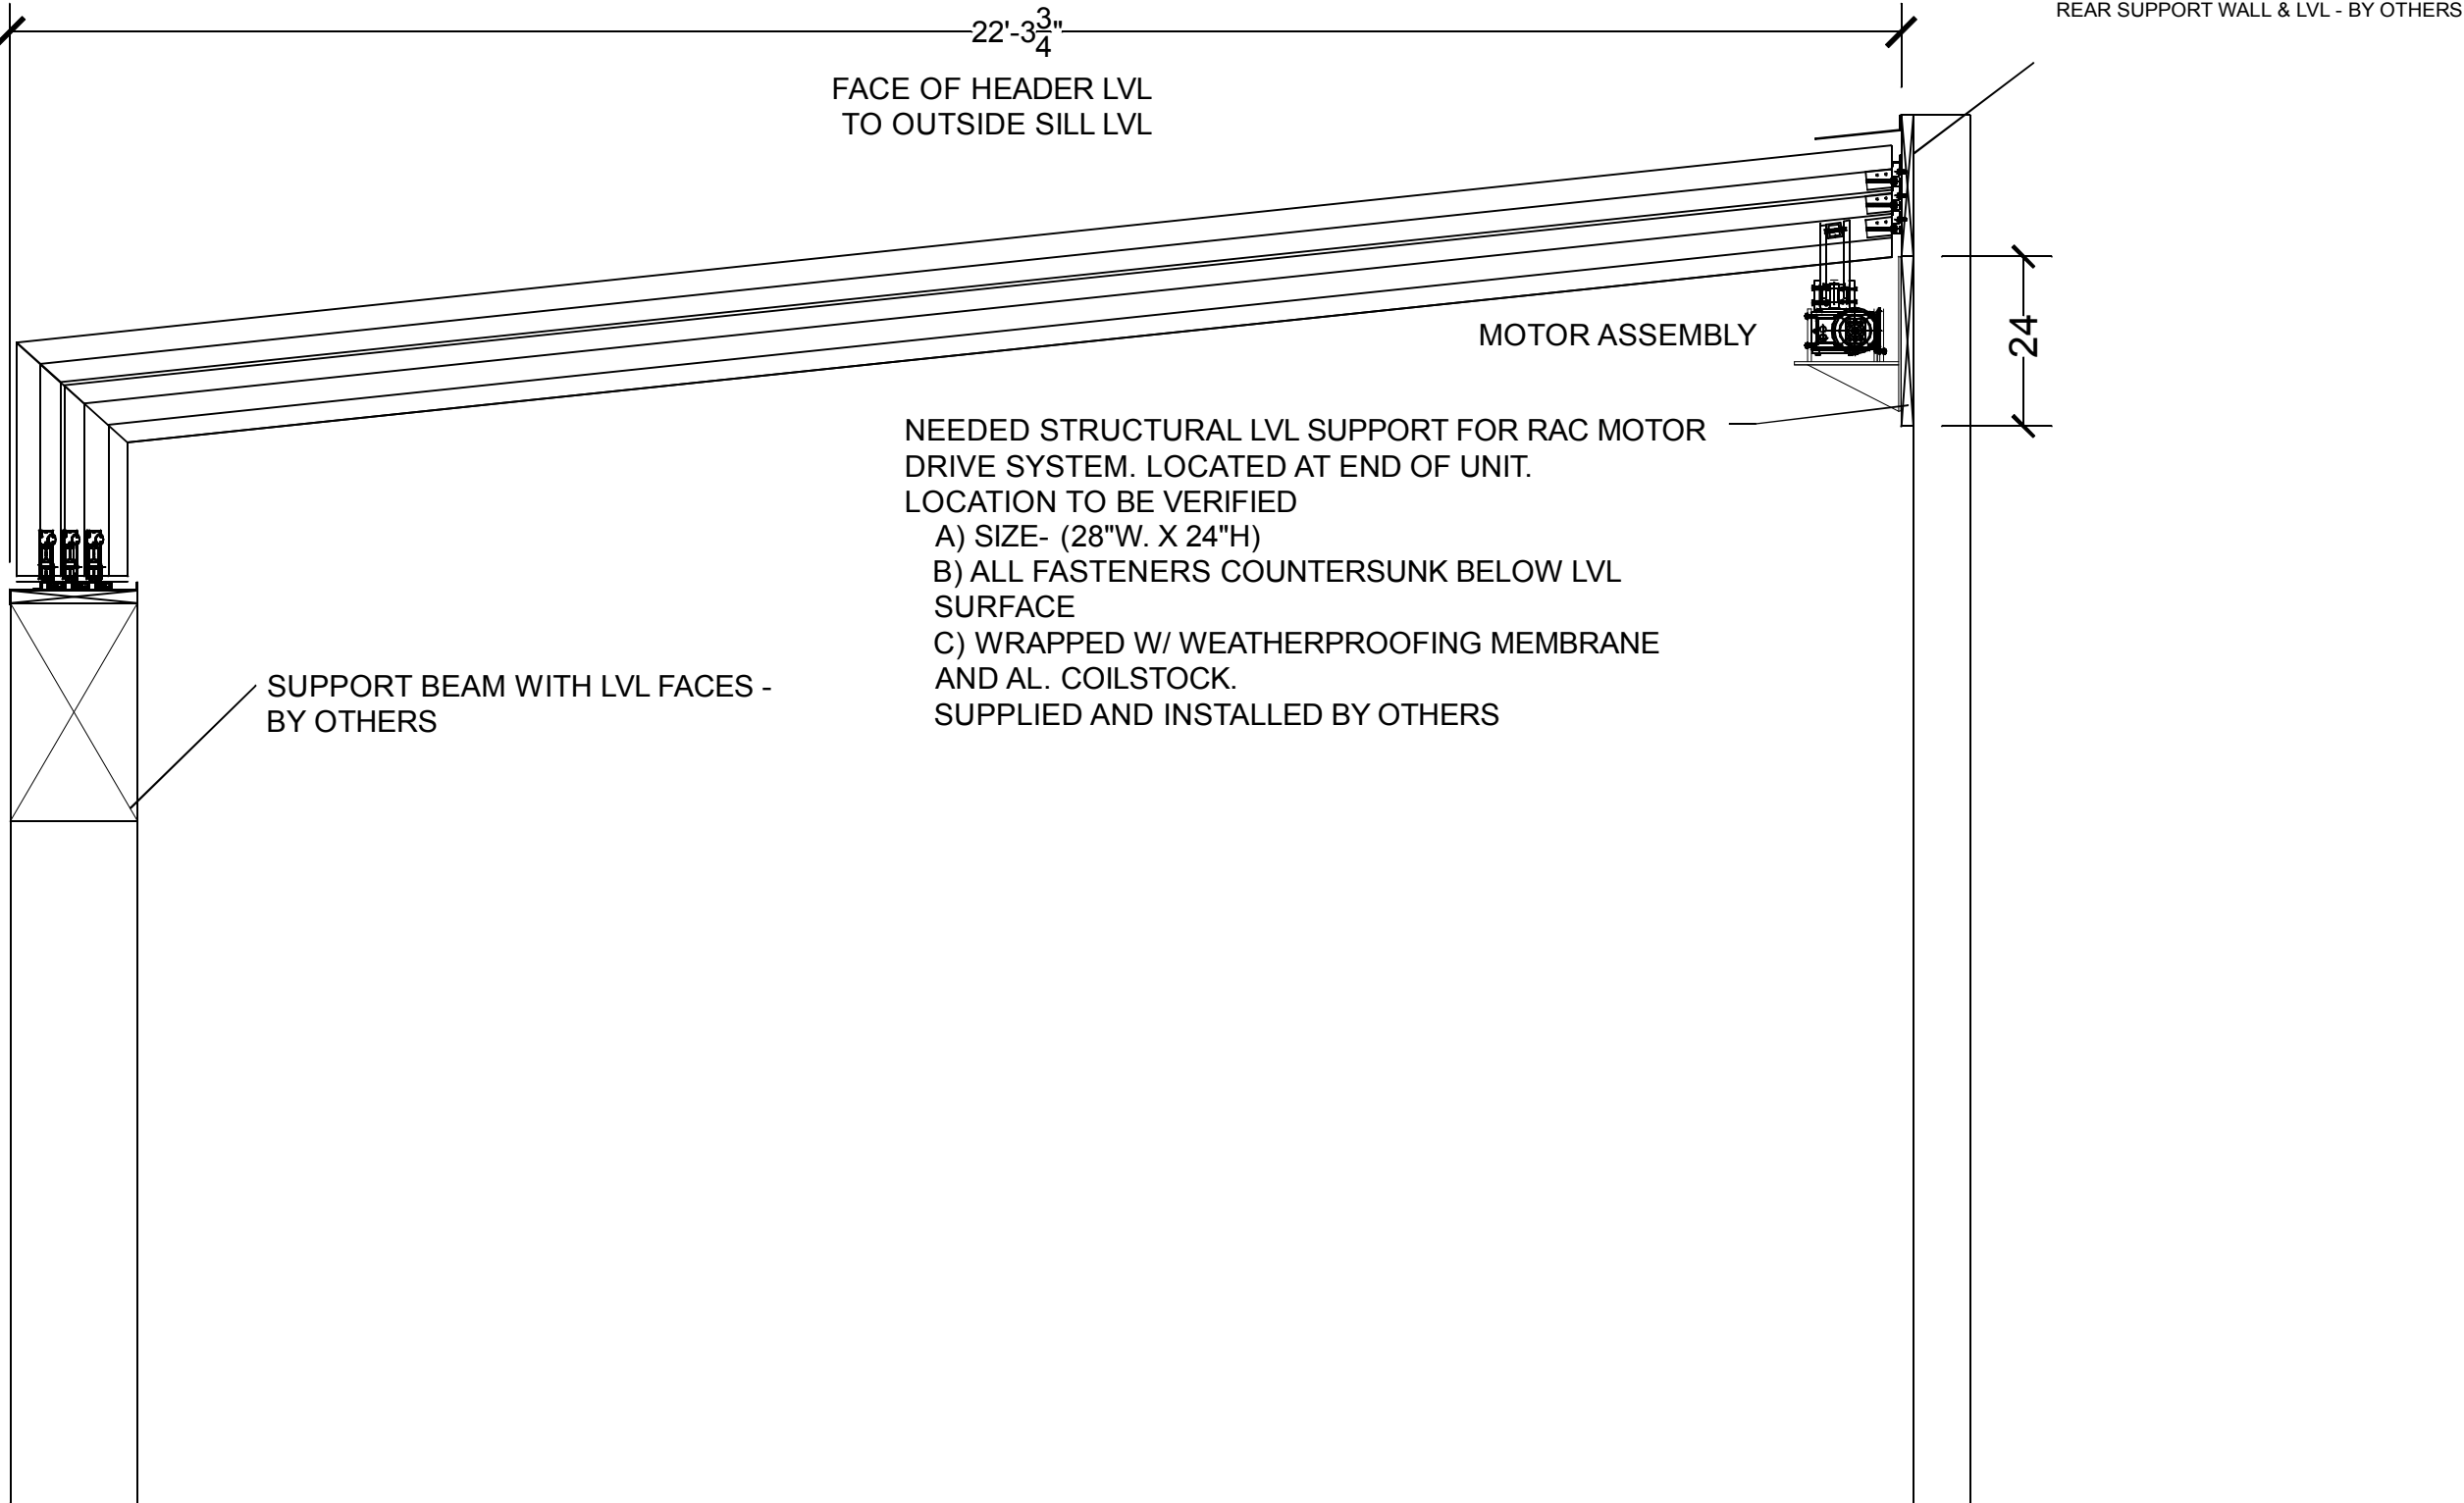

RIGHT SECTION W/ OPENER

DRAWING # ILTS-01	JOB NAME & ADDRESS: INVERT LEAN-TO SKYLIGHT 1 MOTOR		SCALE: 1" = 1'-0"
	ORIGINATION DATE: 09-16-25		SALESMAN: DRAWN BY: K. TAYLOR

ROLL - A - COVER INT ' L

696 AMITY ROAD, SUITE: L4


BETHANY, CT 06524

Tel: 203-393-7292

Fax: 203-286-2012

www.rollacover.com


LEAN-TO - INVERT SKYLIGHT
1 MOTOR

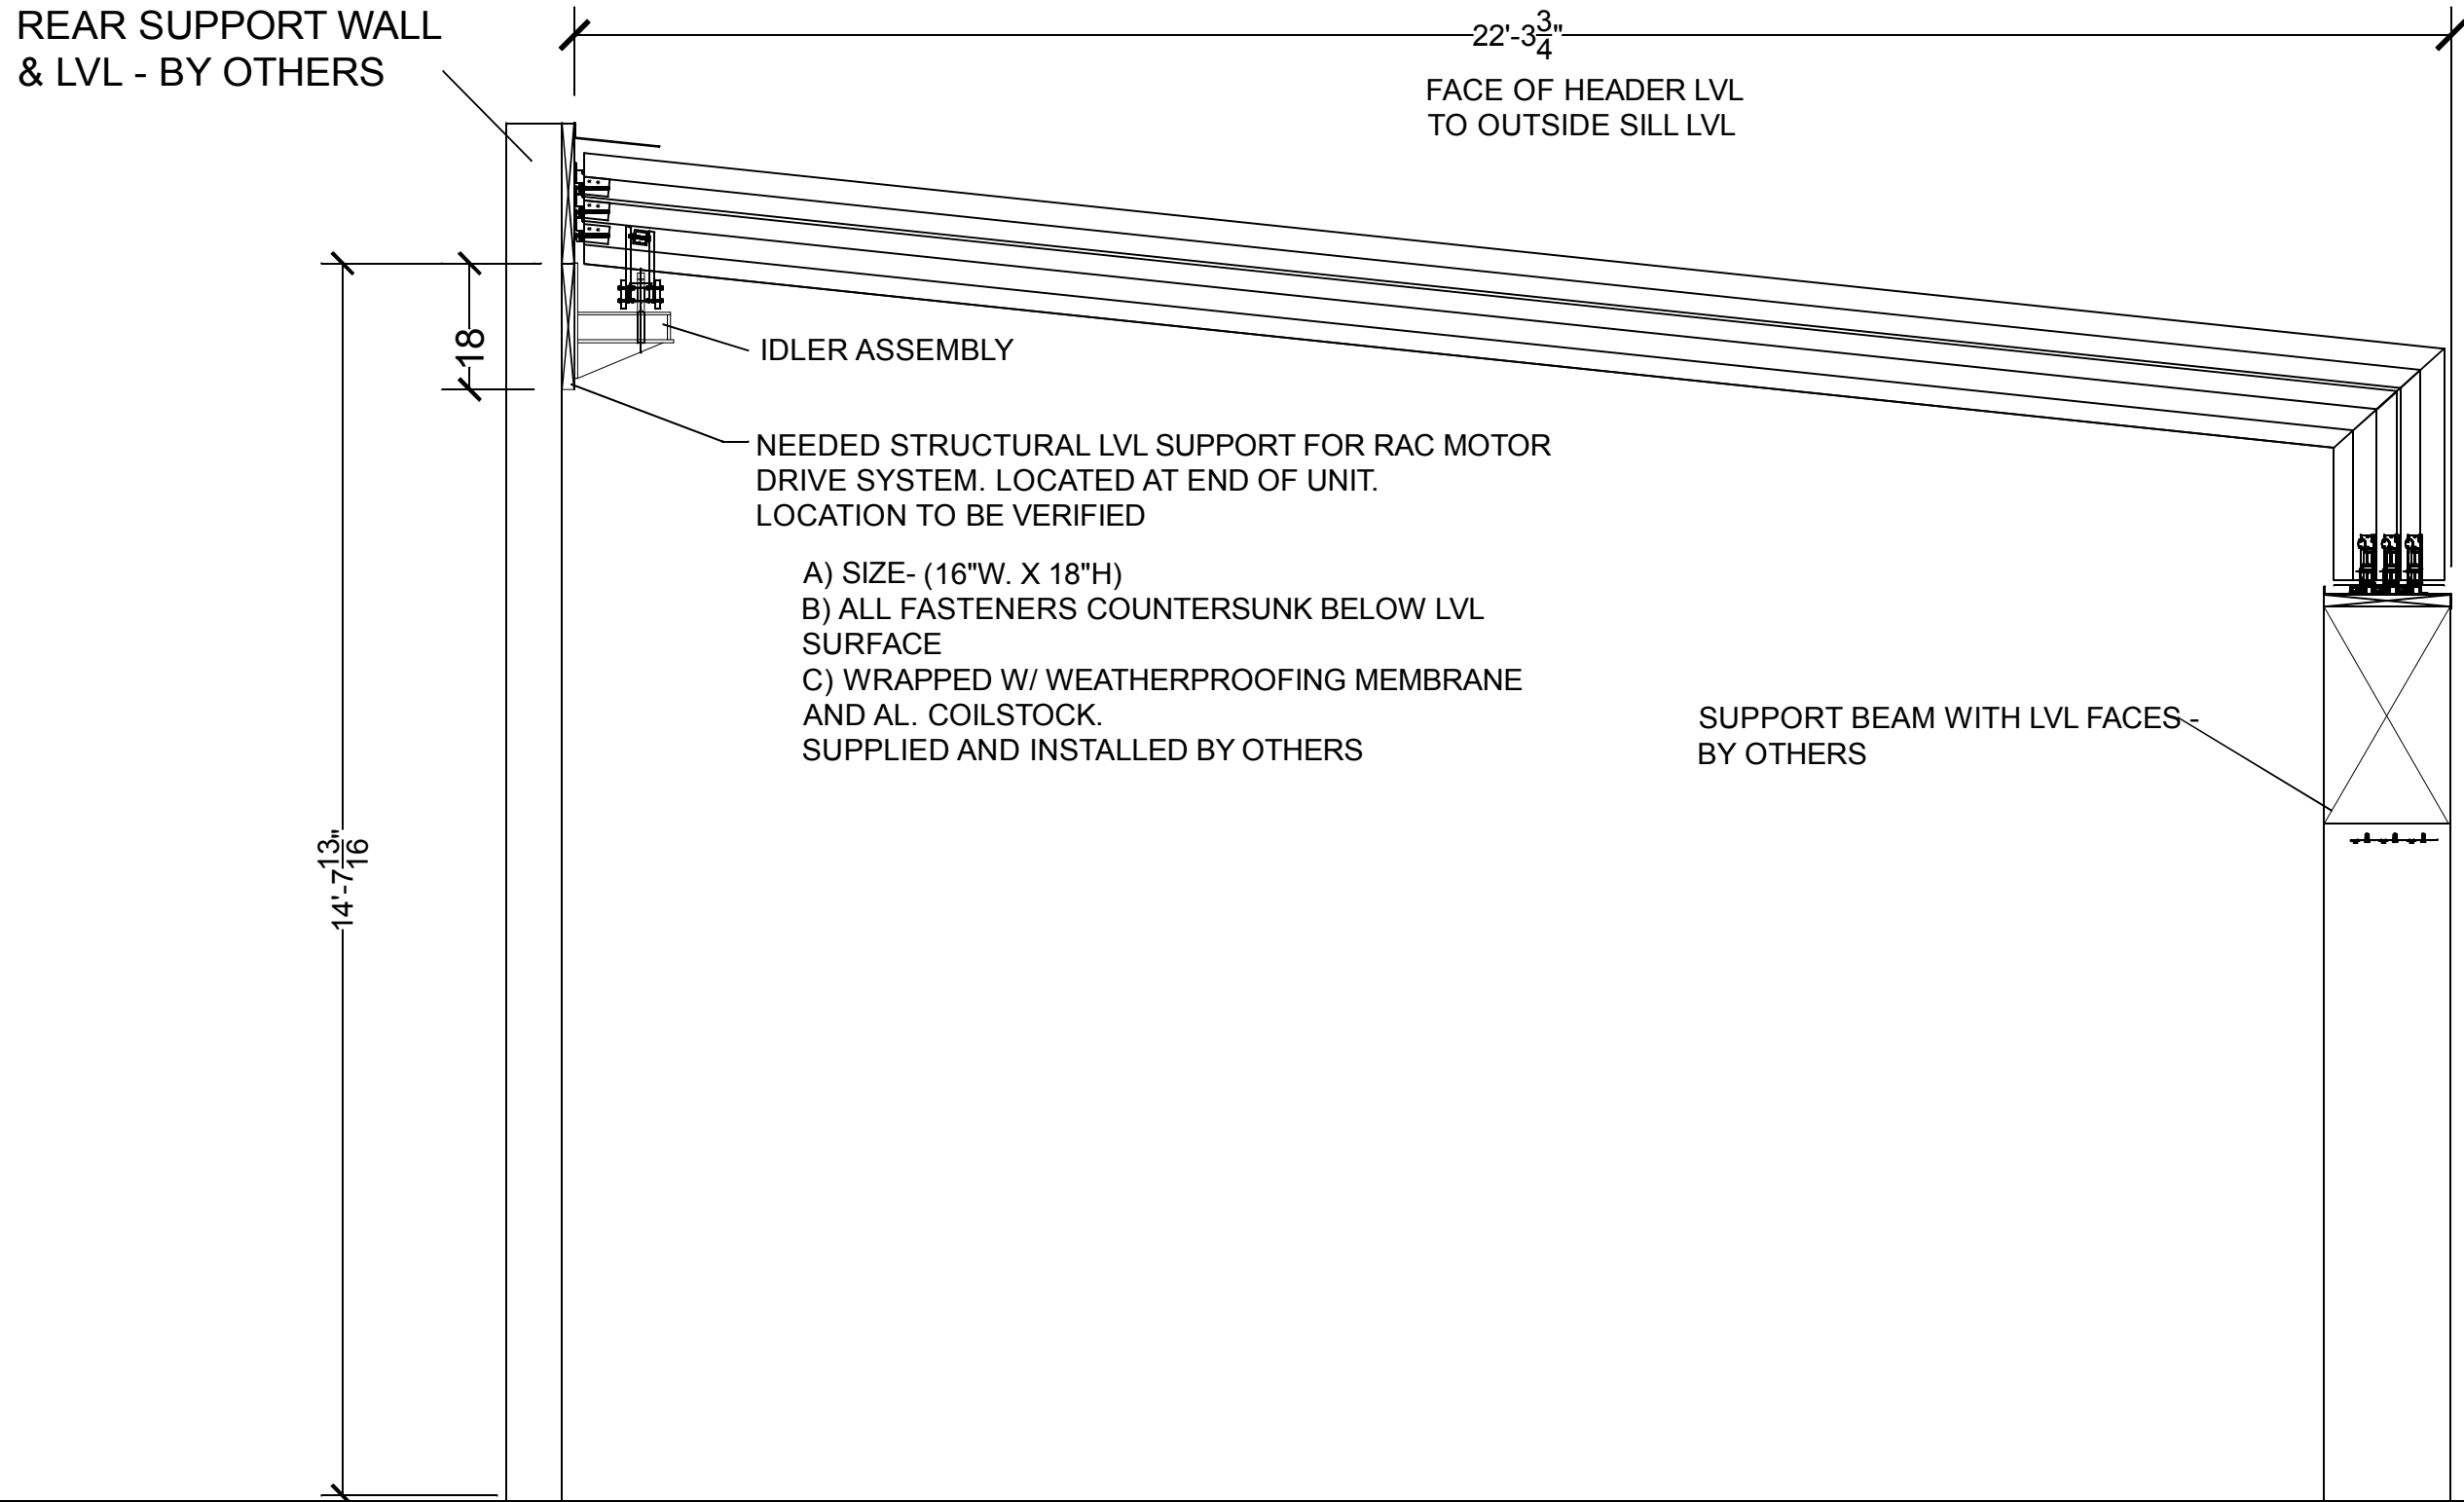

LEFT SECTION W/ OPENER

DRAWING #: ILTS-01	JOB NAME & ADDRESS: INVERT LEAN-TO SKYLIGHT 1 MOTOR		SCALE: 1" = 1'-0"	ROLL - A - COVER INT ' L 696 AMITY ROAD, SUITE: L4 BETHANY, CT 06524		
	ORIGINATION DATE: 09-16-25			SALESMAN: DRAWN BY: K.TAYLOR		
SHEET #: MOTOR	8 OF 10		Tel: 203-393-7292 Fax: 203-286-2012 www.rollacover.com			

LEAN-TO - INVERT SKYLIGHT
1 MOTOR

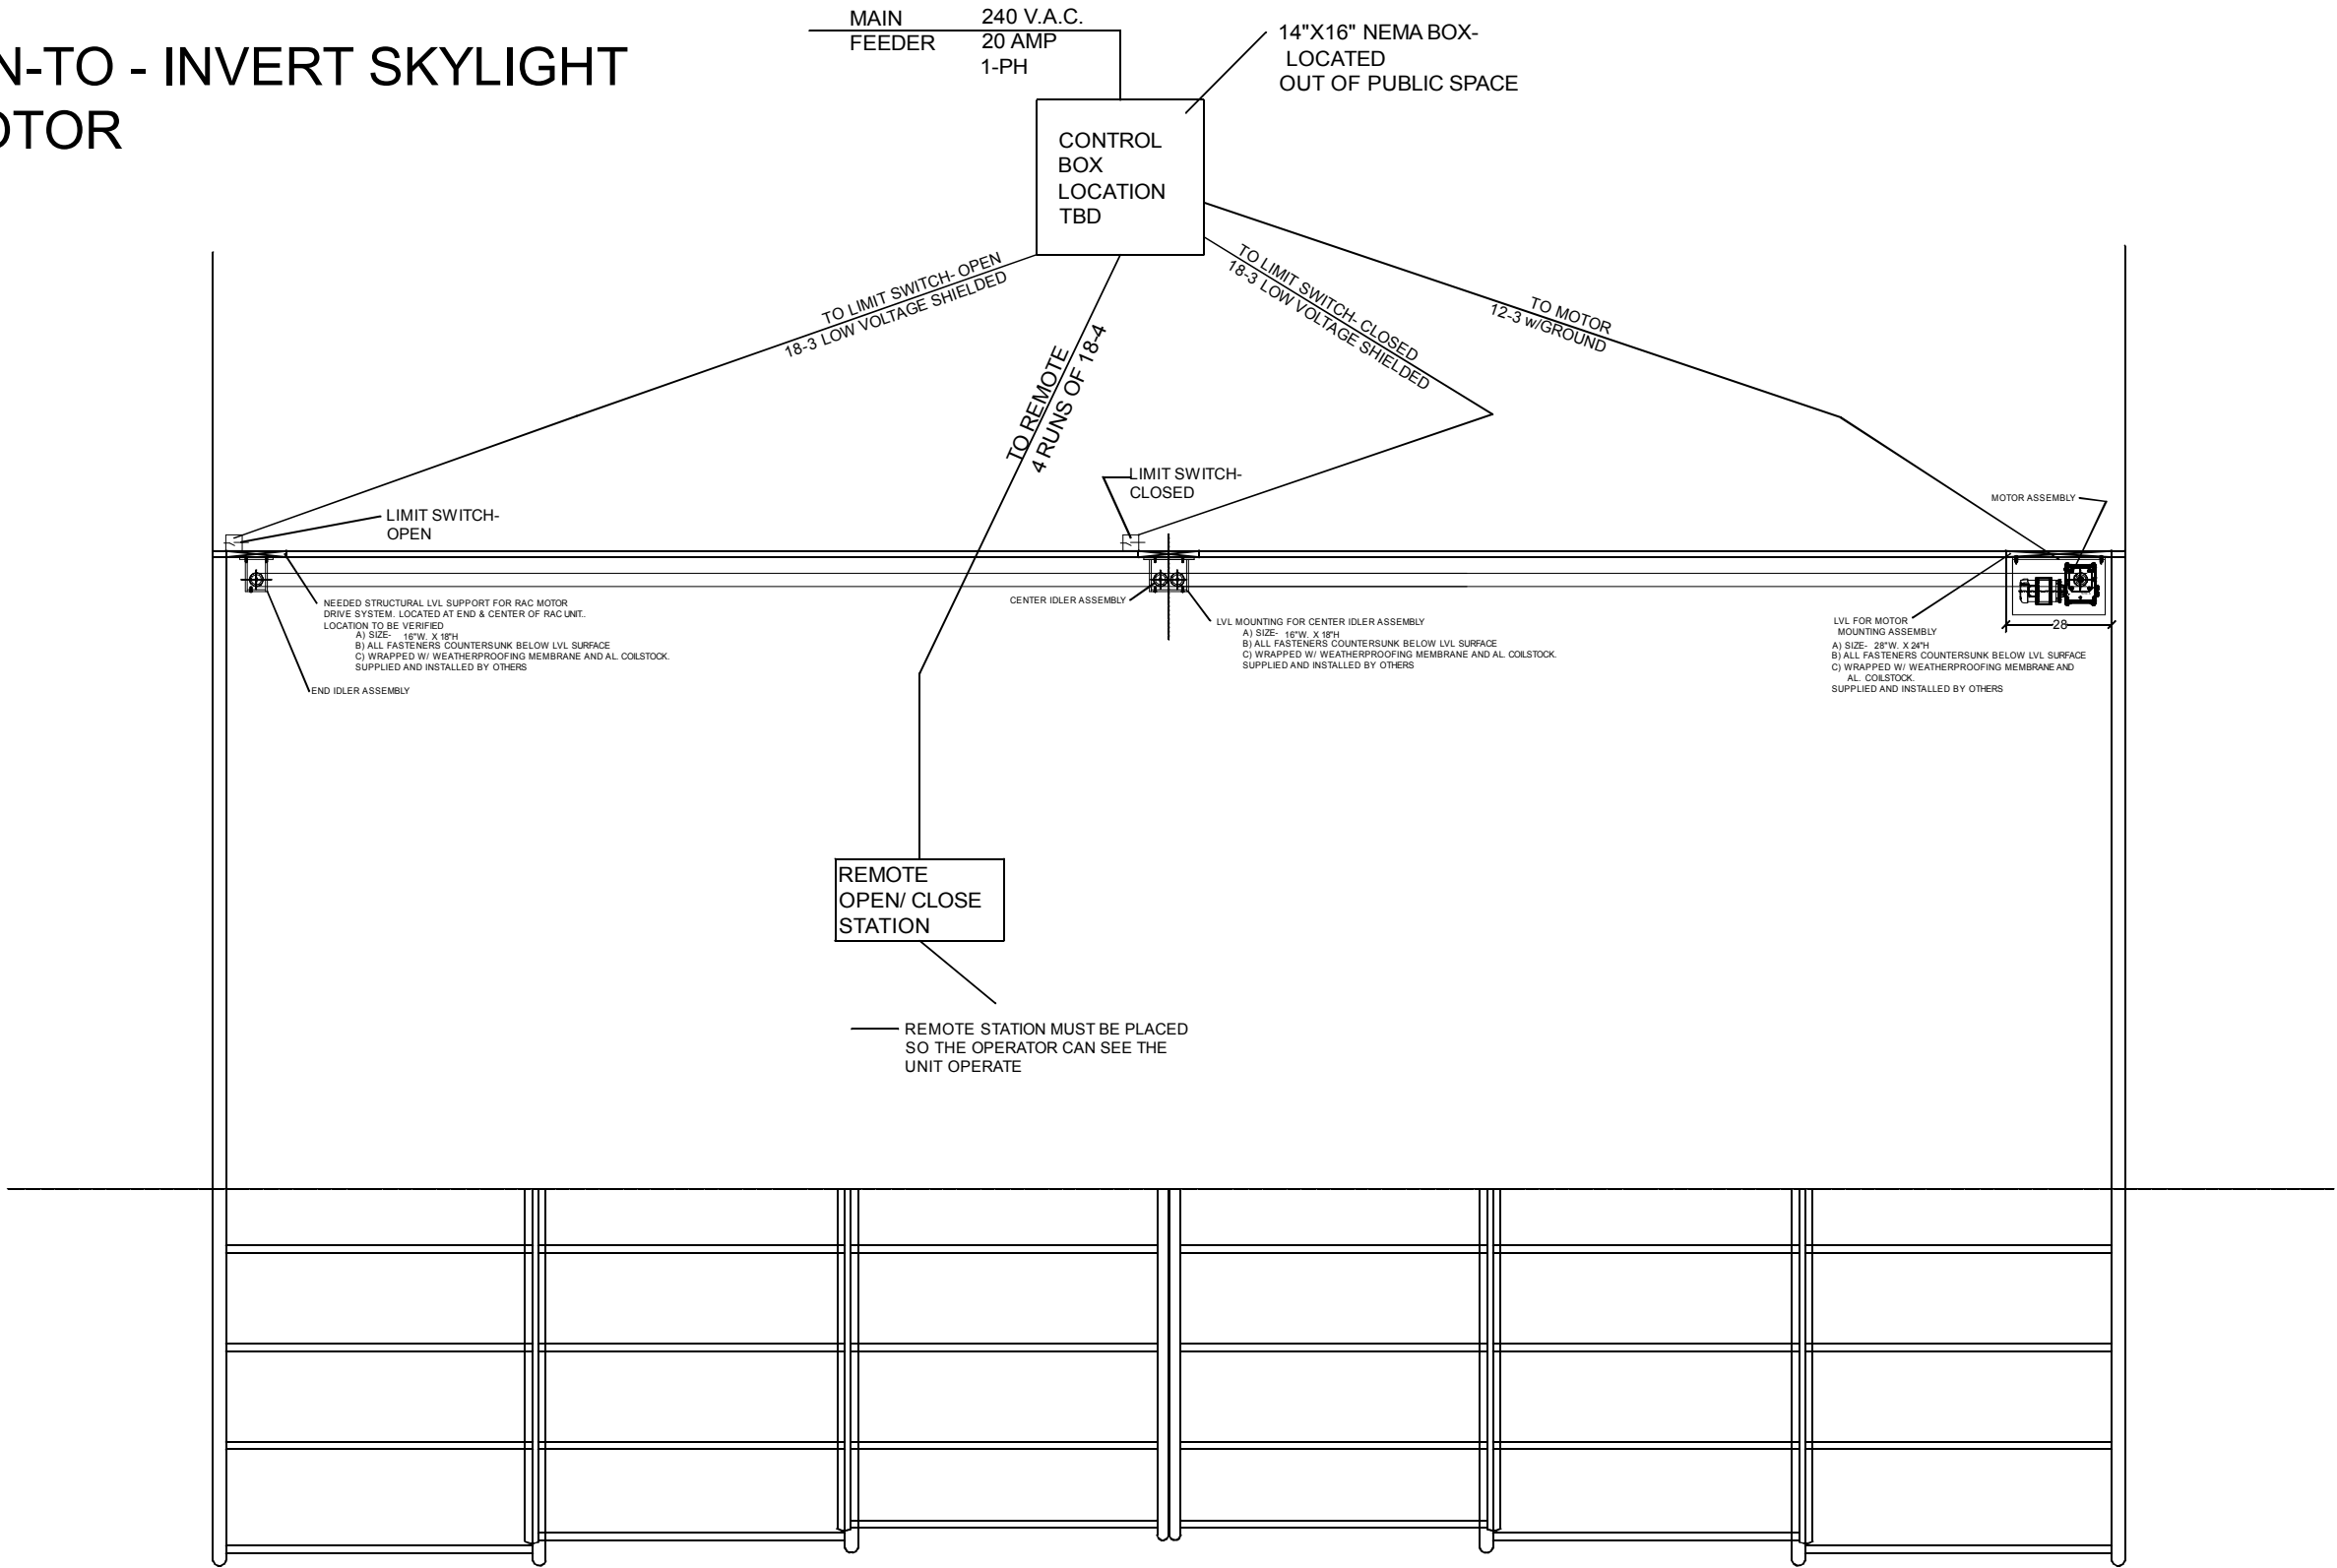

ELECTRICAL LAYOUT

NOTE: STRUCTURAL SUPPORT & LVL BLOCKING BEHIND
ALL MOTOR COMPONENTS - BY OTHERS

- LOCATION- TBD
 - MUST BE INSTALLED STRAIGHT, LEVEL, PLUMB WITH NO DEVIATIONS AND PARALLEL TO REAR HEADER LVL.
 - ALL FASTENERS TO BE COUNTERSUNK BELOW SURFACE
- WRAPPED WITH WEATHERPROOFING MEMBRANE (WATER & ICE) ON TOP BUT NOT GLUED DOWN.
 - PITCHED $\frac{1}{4}$ " PER 1' TO THE OUTSIDE NO LESS, NO MORE.
 - TO BE INSTALLED BY OTHERS

ROLL - A - COVER INT ' L

696 AMITY ROAD, SUITE: L4
BETHANY, CT 06524

www.rollacover.com

Tel: 203-393-7292
Fax: 203-286-2012


SCALE: $\frac{1}{4}" = 1'-0"$	SALESMAN:	DRAWN BY: K. TAYLOR

JOB NAME & ADDRESS: INVERT LEAN-TO SKYLIGHT 1 MOTOR	ORIGINATION	REVISED	REVISED	REVISED
	DATE: 09-16-25			

DRAWING #: ILTS-01	SHEET #: MOTOR 9 OF 10
-----------------------	------------------------------

LEAN-TO - INVERT SKYLIGHT
1 MOTOR

WIRING SCHEMATIC- 1 MOTOR

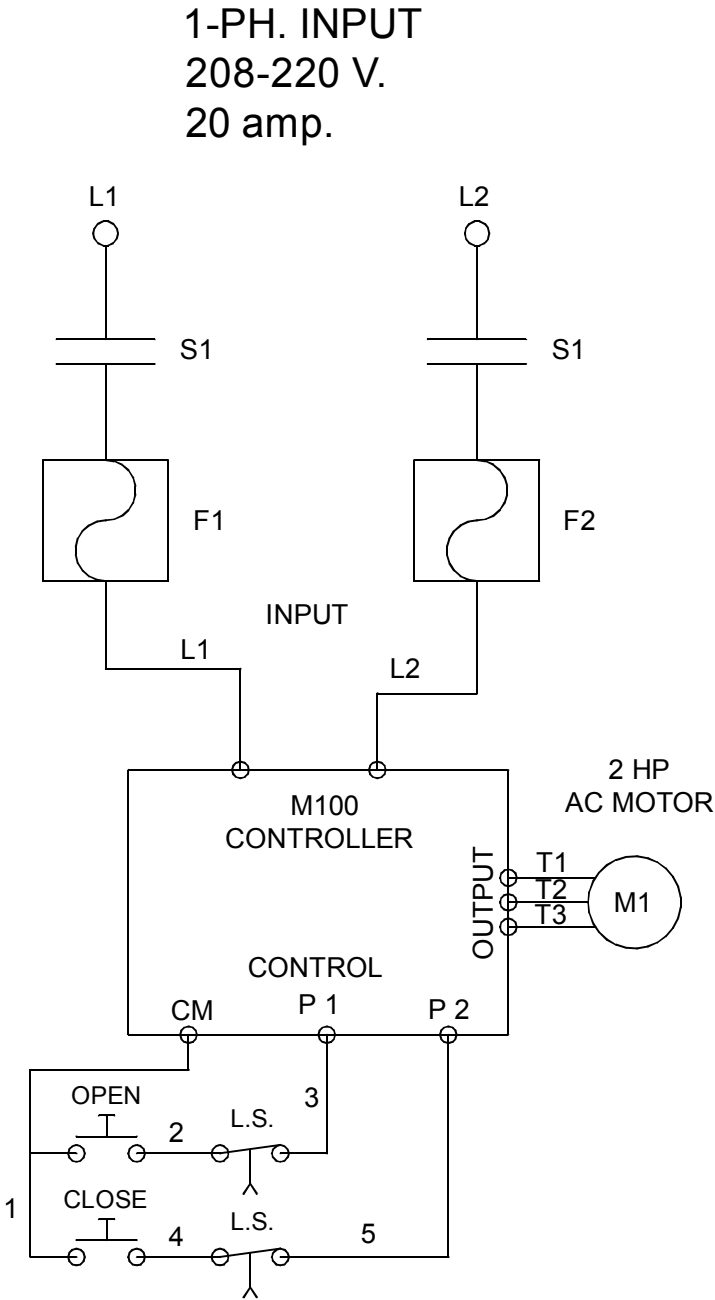

DRAWING #: ILTS-01	JOB NAME & ADDRESS: INVERT LEAN-TO SKYLIGHT 1 MOTOR		SCALE: 1/4" = 1'-0"	ROLL - A - COVER INT ' L 696 AMITY ROAD, SUITE: L4 BETHANY, CT 06524
			SALESMAN:	
SHEET #: MOTOR 10 OF 10	ORIGINATION	REVISED	REVISED	DRAWN BY: K. TAYLOR
DATE:		09-16-25		Tel: 203-393-7292 Fax: 203-286-2012 www.rollacover.com